



3 UPPER FLOOR

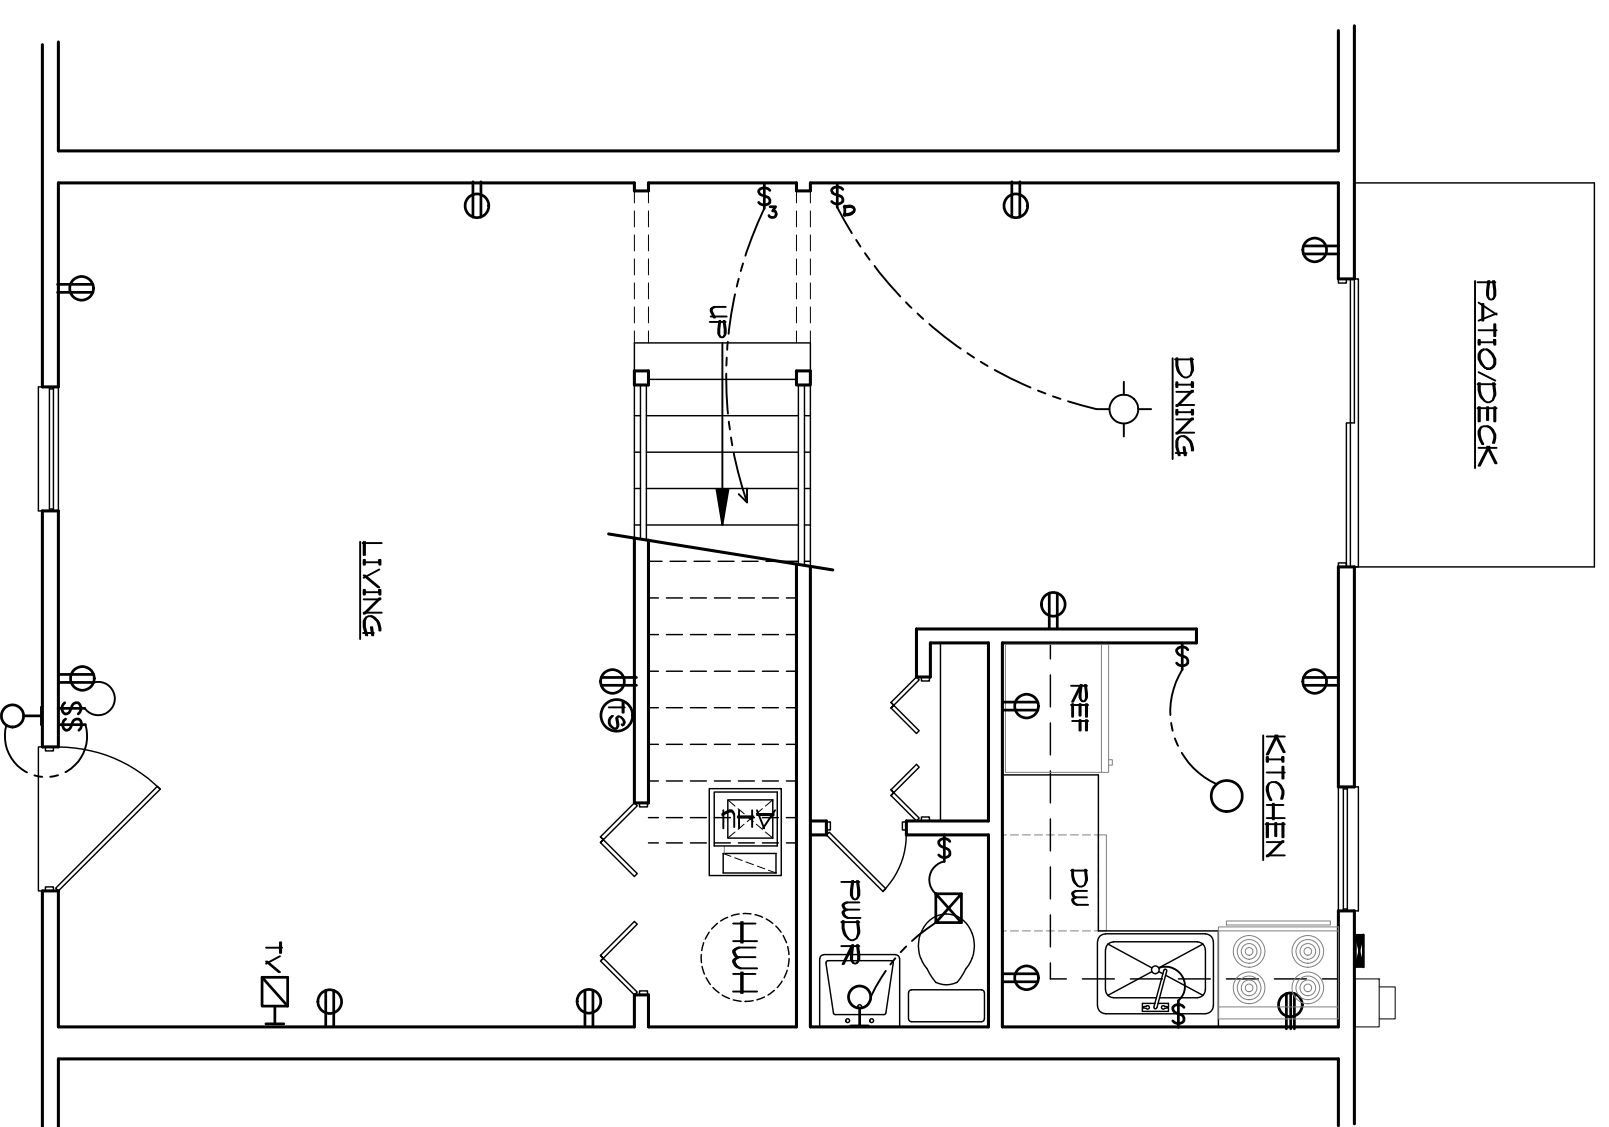

1 MAIN FLOOR

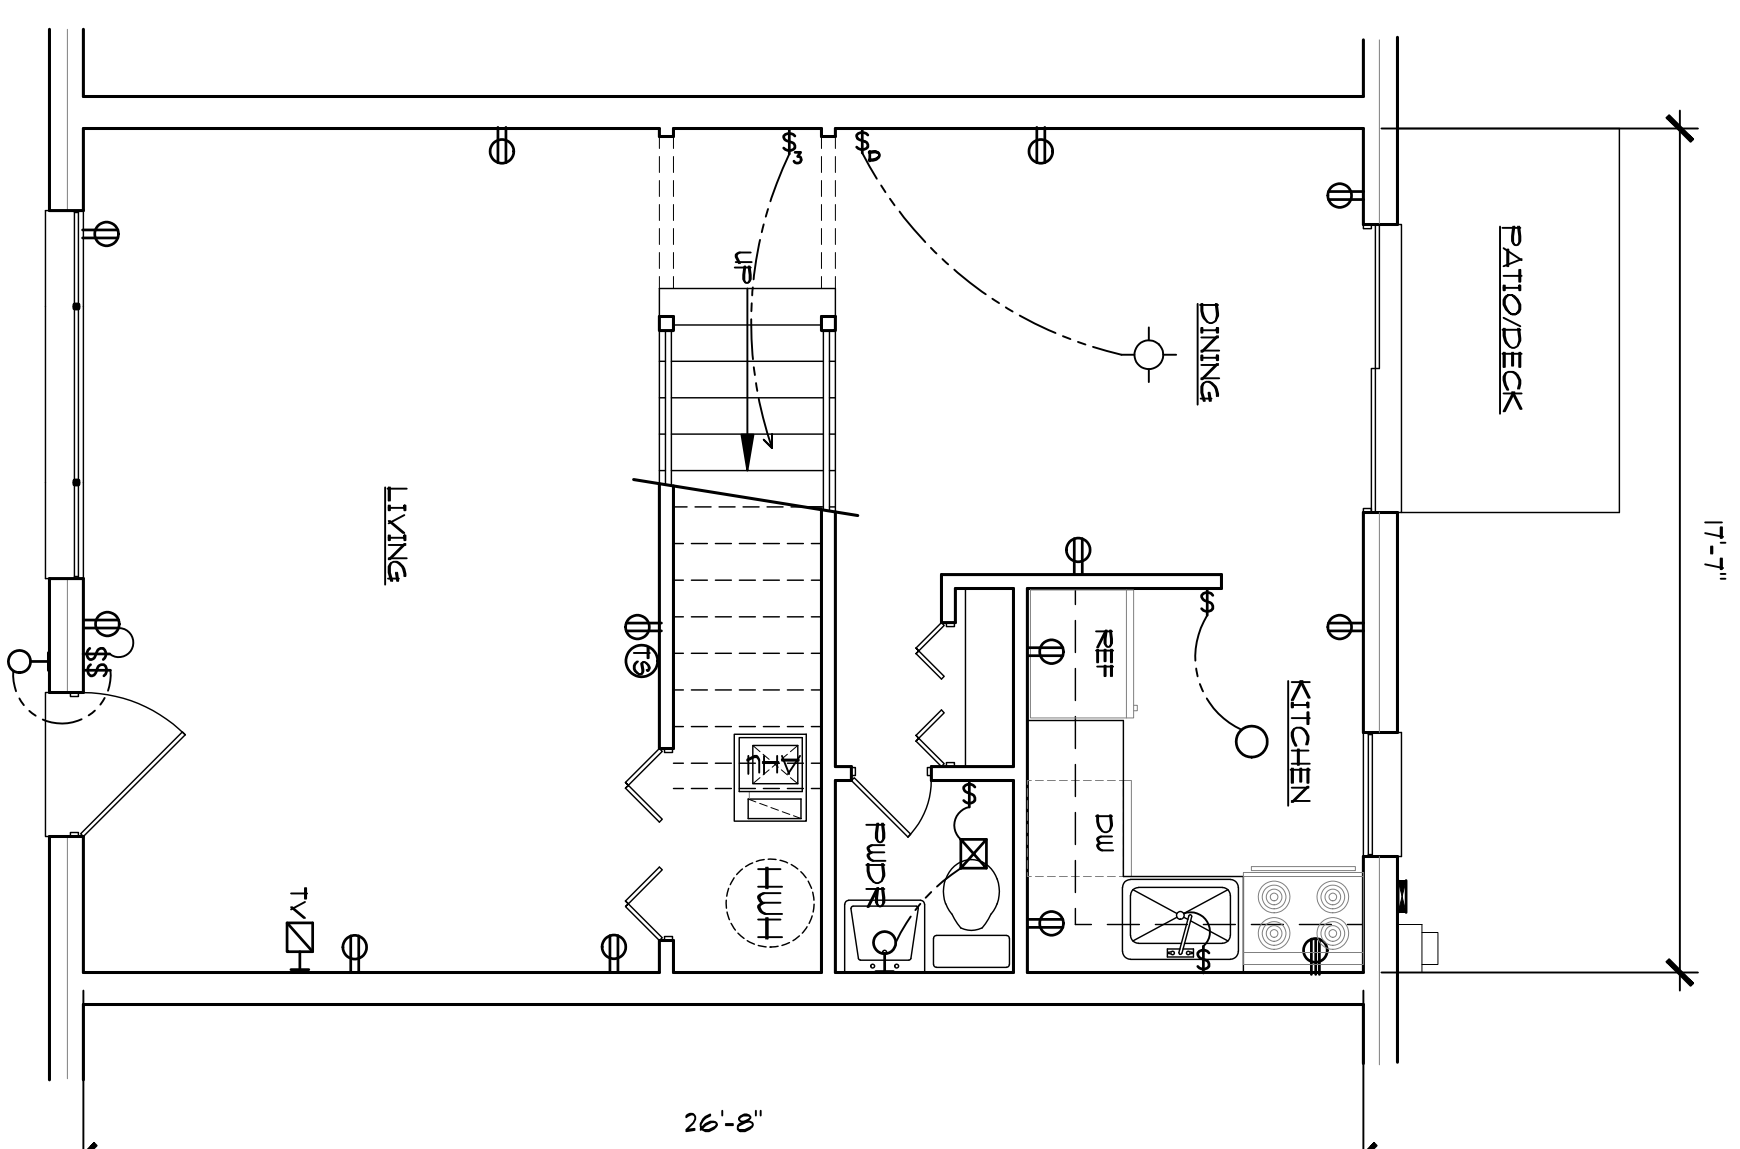

2 MAIN FLOOR - ALTERNATE (BRICK)

SYMBOLS LIST	
	OUTLET FOR CEILING OR WALL MOUNTED FLUORESCENT LIGHTING FIXTURE
	OUTLET FOR CEILING OR WALL MOUNTED INCANDESCENT COMPACT FLUORESCENT OR HID LIGHTING FIXTURE
	CEILING FAN W/ LIGHT KIT
	SINGLE POLE WALL SWITCH
	3-WAY WALL SWITCH
	GENERAL PURPOSE DUPLEX RECEPTACLE
	GROUND FAULT CIRCUIT INTERRUPTER
	CIRCUIT PANEL
	QUICK DISCONNECT
	POWER METER
	AIR HANDLING UNIT
	CONDENSING UNIT
	HVAC SUPPLY GRILLE
	HVAC RETURN GRILLE
	TELEPHONE
	TELEVISION OUTLET
	THERMOSTAT
	HEARING/VISUAL PREPARED SMOKE DETECTOR (BATTERY & HARD-WIRED)
	EMERGENCY CALL SYSTEM PULL CORD STATION
	EMERGENCY CALL ANNUNCIATOR PANEL, SURFACE MNTD, 60" AFE TO CENTERLINE W/ BELL & LIGHT.
	HOT WATER HEATER
	HOSE BIBB
	EXHAUST FAN
	TRACK LIGHT
	DIMMER SWITCH
	240V OUTLET

P.O. Box 78 Charlottesville, VA 22902 (434) 977-2791 (434) 977-0593 (FAX)	
WELLINGTON COURT RENOVATION CHARLOTTESVILLE, VIRGINIA	
NO. DESCRIPTION DATE REVISIONS	EXISTING FLOOR PLAN EXISTING FLOOR PLANS
SCALE 1/4" = 1'-0"	
DATE 12-09-09 DWN BY JDB CHECKED BY RUFJR	
PROJECT NO. V0722	
DRAWING NO. A1	
OF 1	1